


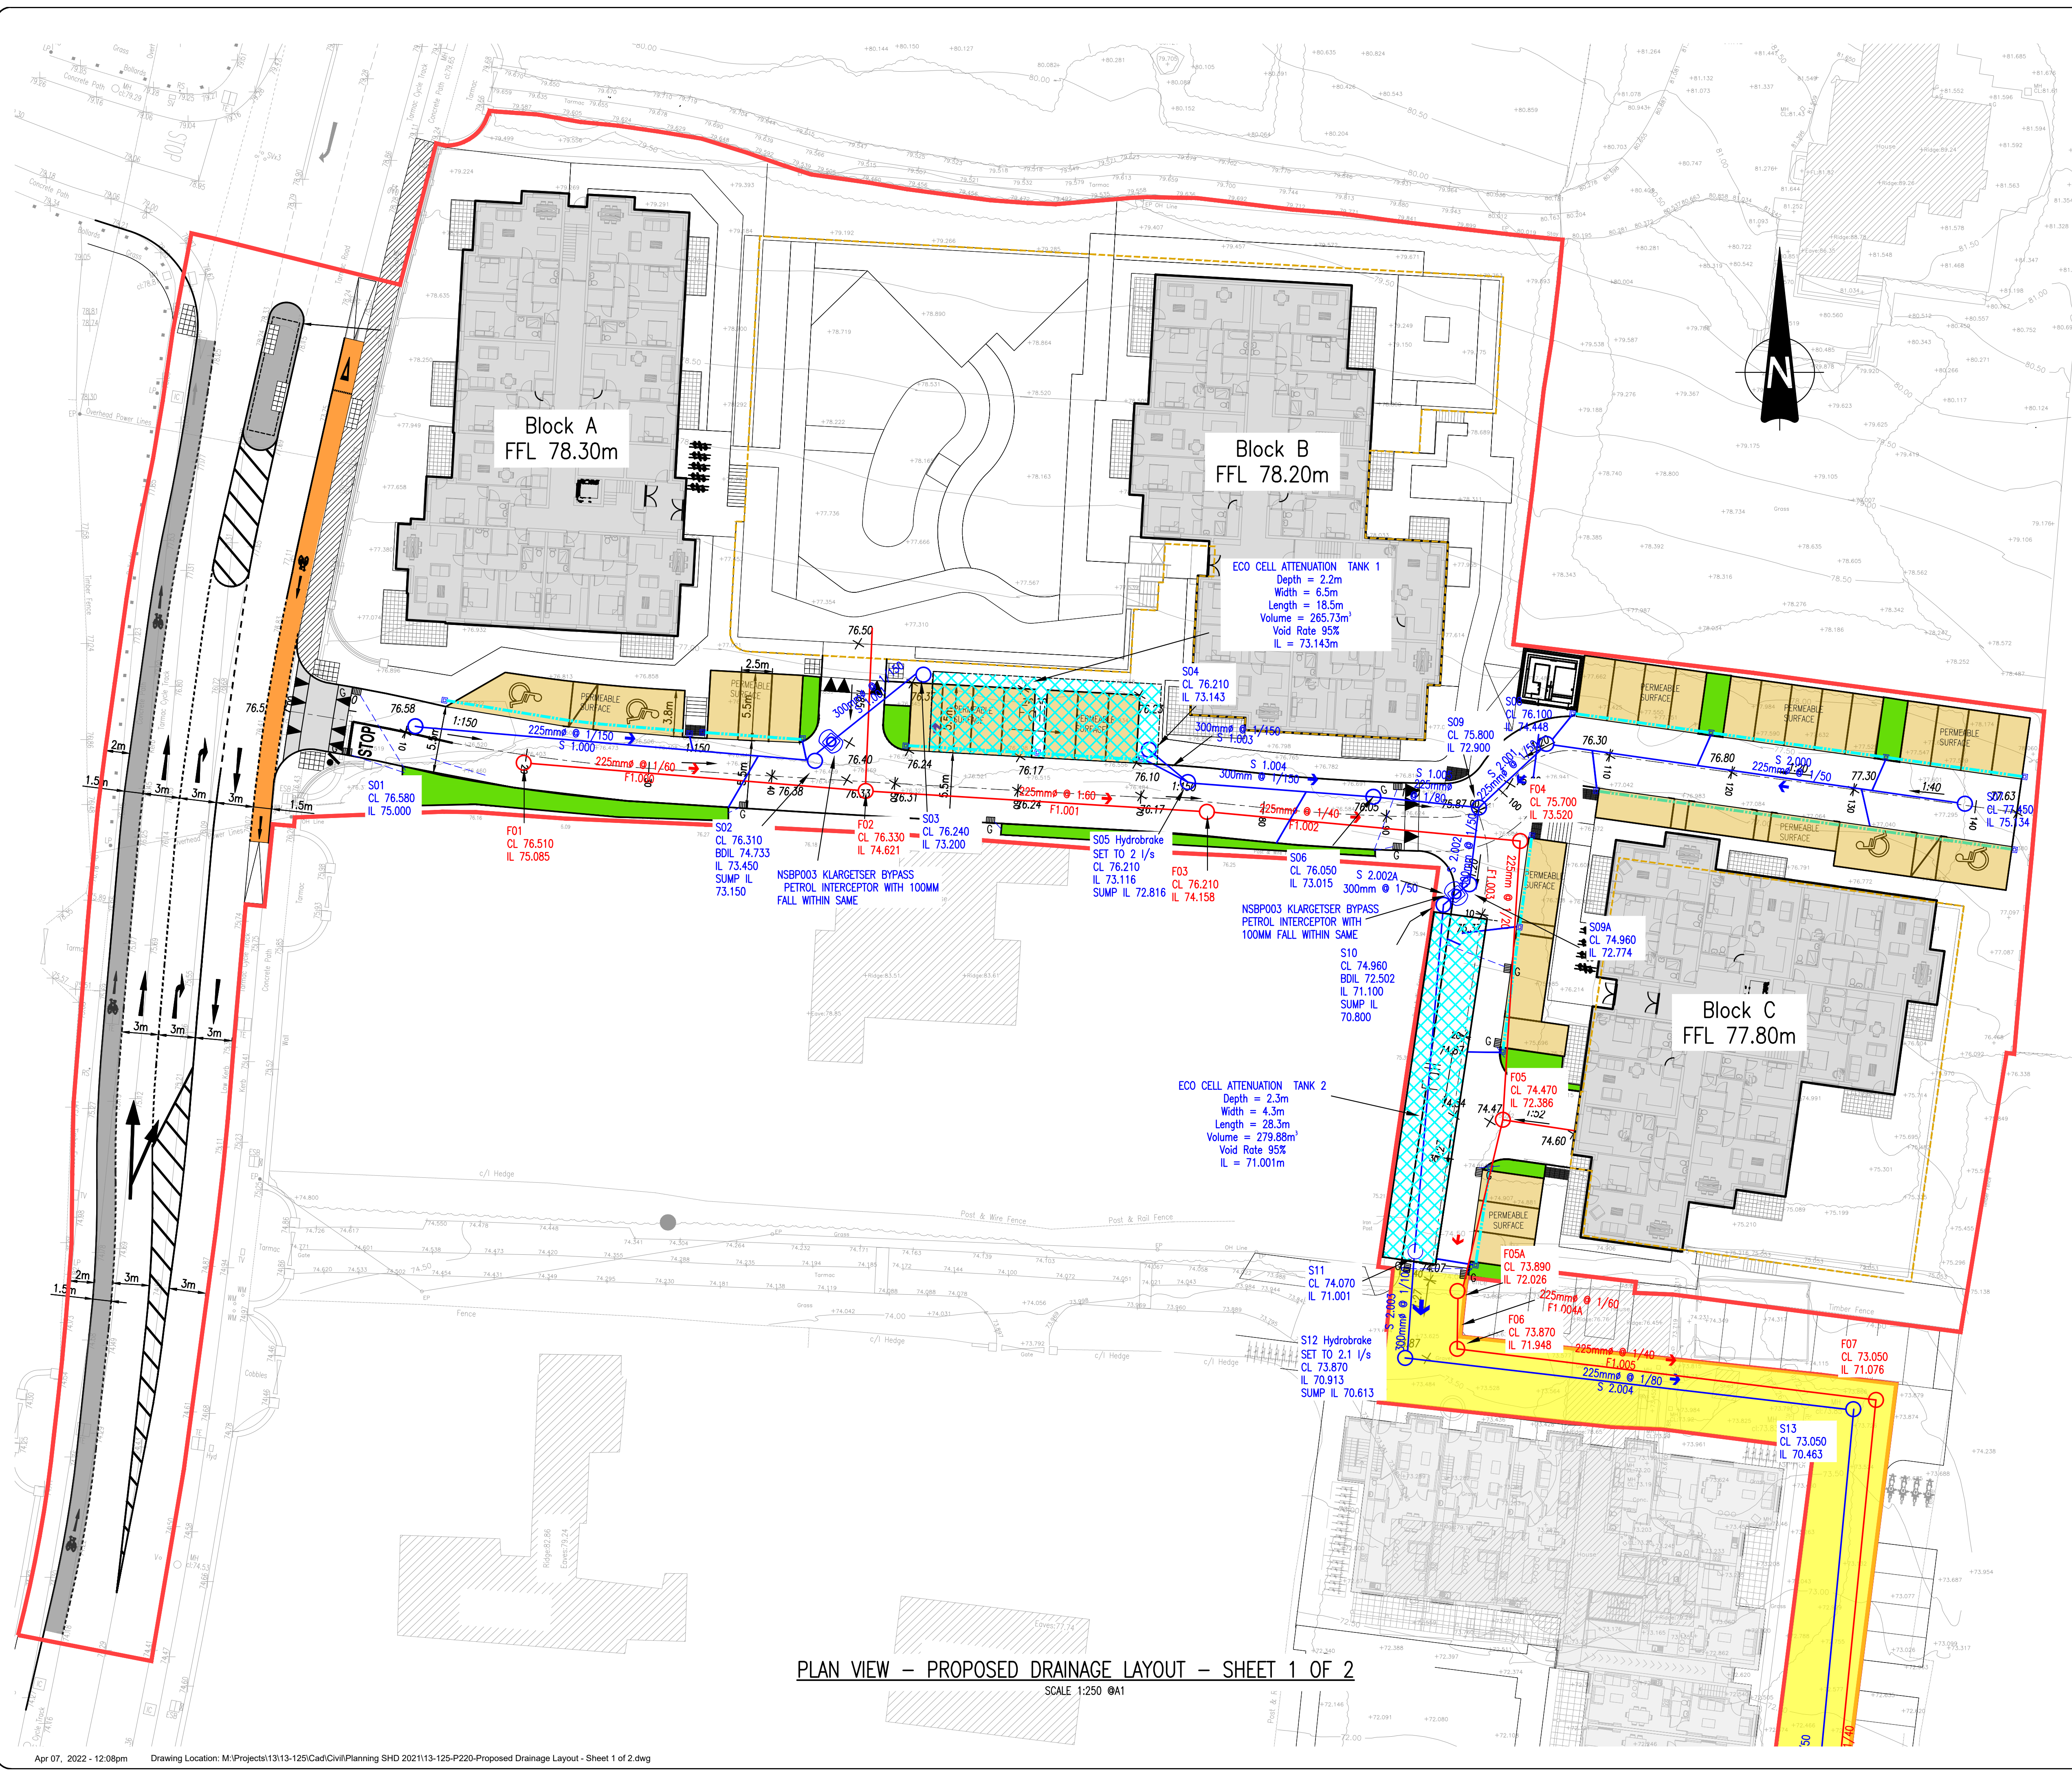

- NOTES:
- DO NOT SCALE. USE FIGURED DIMENSIONS ONLY.
 - THIS DRAWING IS TO BE READ IN CONJUNCTION WITH ALL OTHER RELEVANT ARCHITECTURAL AND ENGINEERING DRAWINGS.

LEGEND:

S08
CL 76.100
IL 74.309

225mm @ 1/20

INDICATES PROPOSED SURFACE WATER SEWER,
PIPE SIZE AND GRADIENT WITH MANHOLE
REFERENCE, COVER AND INVERT LEVELS.

F04
CL 75.700
IL 73.538

225mm @ 1/20

INDICATES PROPOSED FOUL WATER SEWER,
PIPE SIZE AND GRADIENT WITH MANHOLE
REFERENCE, COVER AND INVERT LEVELS.

G

INDICATES PROPOSED ROAD GULLY
AND CONNECTION

PERMEABLE
SURFACE

INDICATES PROPOSED PERMEABLE
PAVED SURFACE AND CONNECTION TO
SURFACE WATER NETWORK

INDICATES DRAINAGE WAYLEAVE

S1_8
CL 71.200m
IL 68.239m

S1_1.1007
CL 71.200m
IL 68.239m

225mm @ 1/41.0

INDICATES SURFACE WATER SEWER,
PIPE SIZE AND GRADIENT WITH MANHOLE
REFERENCE, COVER AND INVERT LEVELS.
APPROVED UNDER PLANNING REG. REF. D16a/O260

F8
CL 71.200m
IL 69.460m

225mm @ 1/33


INDICATES FOUL WATER SEWER,
PIPE SIZE AND GRADIENT WITH MANHOLE
REFERENCE, COVER AND INVERT LEVELS.
APPROVED UNDER PLANNING REG. REF. D16a/O260

INDICATES EXTENT OF PLANNING
APPLICATION BOUNDARY

INDICATES PETROL INTERCEPTOR

INDICATES UNDERGROUND ATTENUATION TANK

INDICATES PROPOSED TREE PIT LOCATION

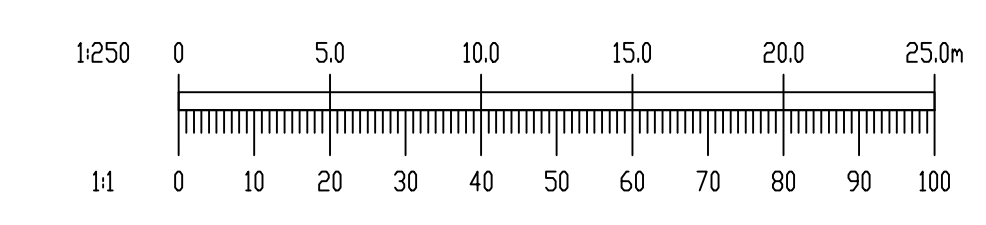

Ordnance Survey Ireland

Ordnance Survey Ireland Licence
No. EN 0006021 © Ordnance Survey
Ireland/Government of Ireland.

B	22/03/22	UPDATE FOR IRISH WATER SUBMISSION	JR	RM
A	10/03/22	UPDATE FOR SW AUDIT RESPONSE	JR	RM
REV.	DATE	AMENDMENT	DRN	APPD

STATUS **FOR PLANNING ONLY
NOT FOR CONSTRUCTION**

Waterman Moylan
Engineering Consultants

BLOCK S, EASTPOINT BUSINESS PARK, ALFIE BYRNE ROAD,
DUBLIN D03 H3F4 IRELAND. Tel: (01) 664 8900
Email: info@waterman-moylan.ie www.waterman-moylan.ie

CLIENT	MORAN PARK HOMEBUILDERS LIMITED
ARCHITECT	MC GRANE AND PARTNERS LTD.
PROJECT	STRATEGIC HOUSING DEVELOPMENT AT GLENAMUCK ROAD NORTH, CARRICKMINES, DUBLIN 18
TITLE	PROPOSED DRAINAGE LAYOUT SHEET 1 OF 2

DRAWN G.Byrne	DESIGNED IW	APPROVED JG	DATE FEB. '22
SCALE 1:250 @A1	JOB NO. 13-125	DRG. NO. P220	REVISION B

© 2017. This drawing is copyright. No part of this document may be reproduced or transmitted in any form or stored in any retrieval system of any nature without the written permission of the copyright owner. All rights reserved.

PLAN VIEW – PROPOSED DRAINAGE LAYOUT – SHEET 1 OF 2
SCALE 1:250 @A1