



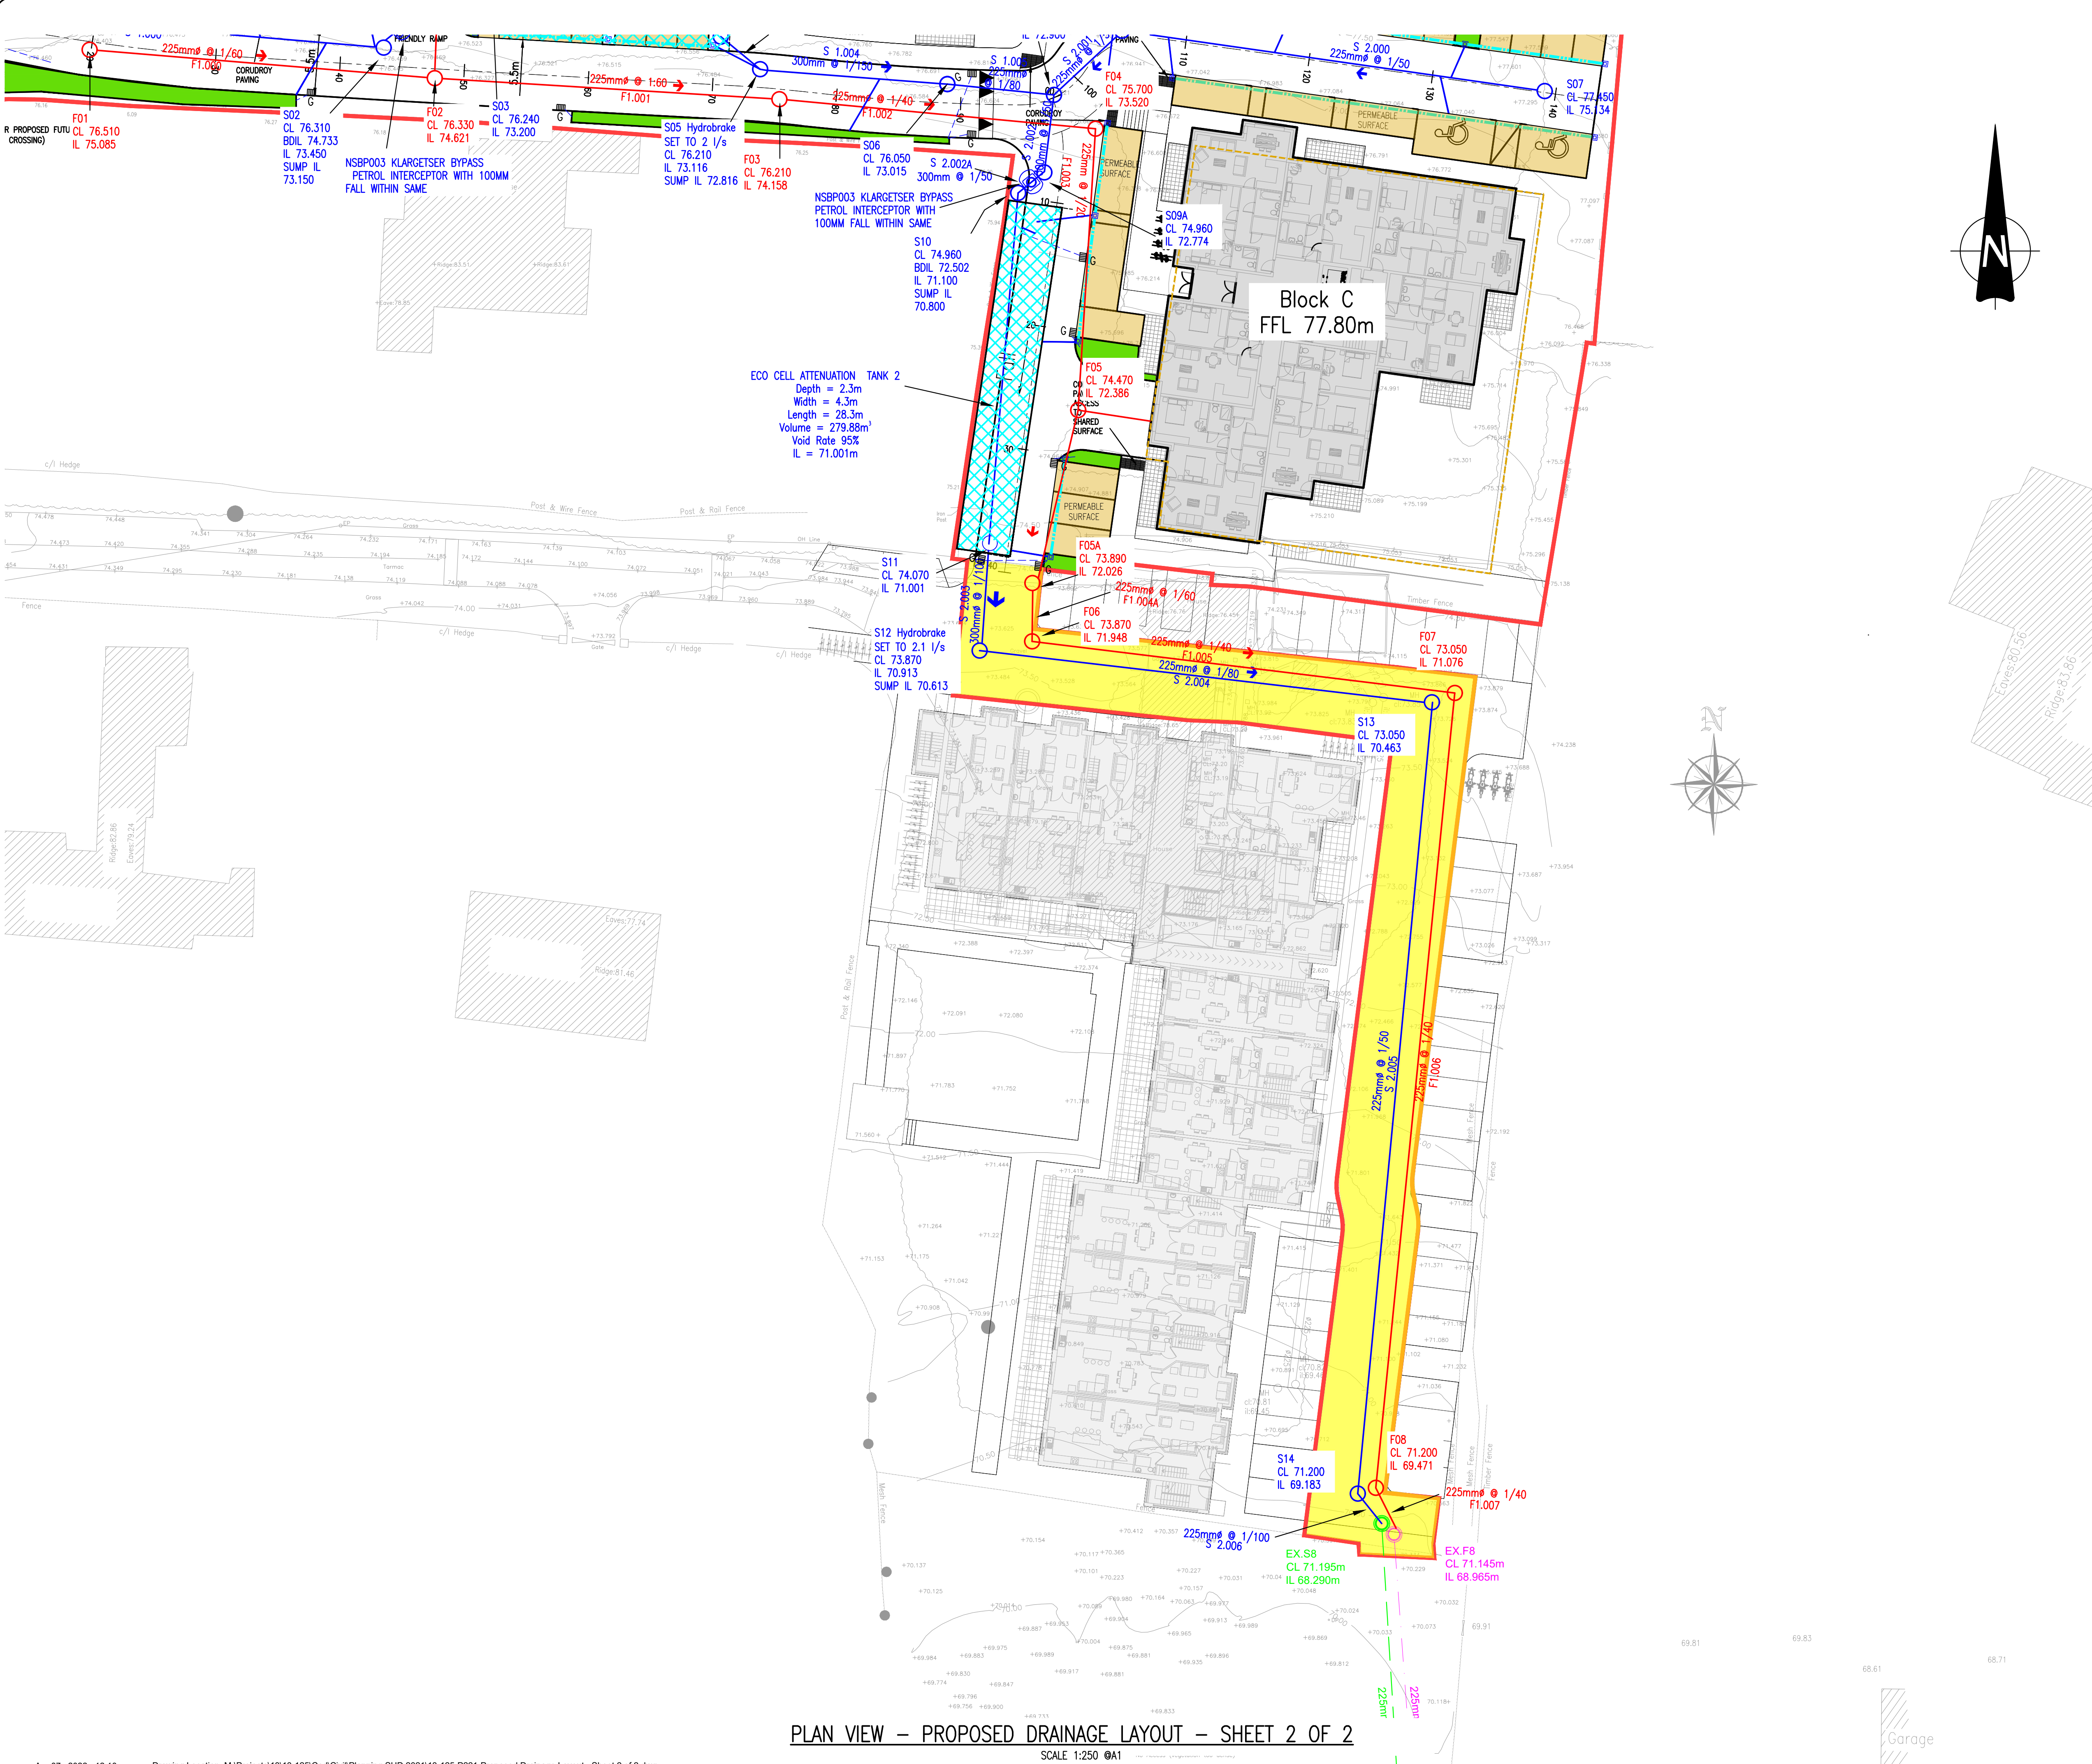

- NOTES:
- DO NOT SCALE. USE FIGURED DIMENSIONS ONLY.
 - THIS DRAWING IS TO BE READ IN CONJUNCTION WITH ALL OTHER RELEVANT ARCHITECTURAL AND ENGINEERING DRAWINGS.

LEGEND:

- S08
CL 76.100
IL 74.309
- 225mm ϕ 1/20
- INDICATES PROPOSED SURFACE WATER SEWER,
PIPE SIZE AND GRADIENT WITH MANHOLE
REFERENCE, COVER AND INVERT LEVELS.
- F04
CL 75.700
IL 73.538
- 225mm ϕ 1/20
- INDICATES PROPOSED FOUL WATER SEWER,
PIPE SIZE AND GRADIENT WITH MANHOLE
REFERENCE, COVER AND INVERT LEVELS.
- G
- INDICATES PROPOSED ROAD GULLY
AND CONNECTION
- PERMEABLE SURFACE
- INDICATES PROPOSED PERMEABLE
PAVED SURFACE AND CONNECTION TO
SURFACE WATER NETWORK
- INDICATES DRAINAGE WAYLEAVE
- S1.8
CL 71.200m
IL 68.239m
- S1.1.1007
CL 71.200m
IL 68.239m
- 225mm ϕ 1/40
- INDICATES SURFACE WATER SEWER,
PIPE SIZE AND GRADIENT WITH MANHOLE
REFERENCE, COVER AND INVERT LEVELS.
APPROVED UNDER PLANNING REG. REF. D16A/0260
- F8
CL 71.200m
IL 69.460m
- 225mm ϕ 1/33
- INDICATES FOUL WATER SEWER,
PIPE SIZE AND GRADIENT WITH MANHOLE
REFERENCE, COVER AND INVERT LEVELS.
APPROVED UNDER PLANNING REG. REF. D16A/0260
- INDICATES EXTENT OF PLANNING
APPLICATION BOUNDARY
- INDICATES PETROL INTERCEPTOR
- INDICATES UNDERGROUND ATTENUATION TANK
- INDICATES PROPOSED TREE PIT LOCATION

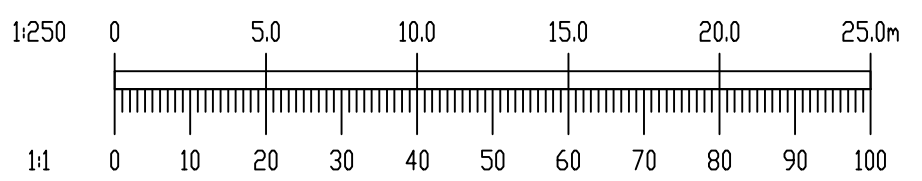

Ordnance Survey Ireland
Ordnance Survey Ireland Licence
No. EN 0006021 © Ordnance Survey
Ireland/Government of Ireland.

B	22/03/22	UPDATE FOR IRISH WATER SUBMISSION	JR	RM
A	10/03/22	UPDATE FOR SW AUDIT RESPONSE	JR	RM
REV.	DATE	AMENDMENT	DRN	APPD

STATUS **FOR PLANNING ONLY
NOT FOR CONSTRUCTION**

Waterman Moylan
Engineering Consultants
BLOCK S, EASTPOINT BUSINESS PARK, ALFIE BYRNE ROAD,
DUBLIN D03 H3F4 IRELAND. Tel: (01) 664 8900
Email: info@waterman-moylan.ie www.waterman-moylan.ie

CLIENT **MORAN PARK HOMEBUILDERS LIMITED**
ARCHITECT **MC GRANE AND PARTNERS LTD.**

PROJECT **STRATEGIC HOUSING DEVELOPMENT
AT GLENAMUCK ROAD NORTH,
CARRICKMINES, DUBLIN 18**

TITLE **PROPOSED DRAINAGE LAYOUT
SHEET 2 OF 2**

DRAWN G.Byrne	DESIGNED IW	APPROVED JG	DATE FEB. '22
SCALE 1:250 @A1	JOB NO. 13-125	DRG. NO. P221	REVISION B

© 2017. This drawing is copyright. No part of this document may be re-produced or transmitted in any form or stored in any retrieval system of any nature without the written permission of the copyright holder except as agreed for use on the project for which the document was originally issued.

PLAN VIEW – PROPOSED DRAINAGE LAYOUT – SHEET 2 OF 2

SCALE 1:250 @A1